




1 3D View 1

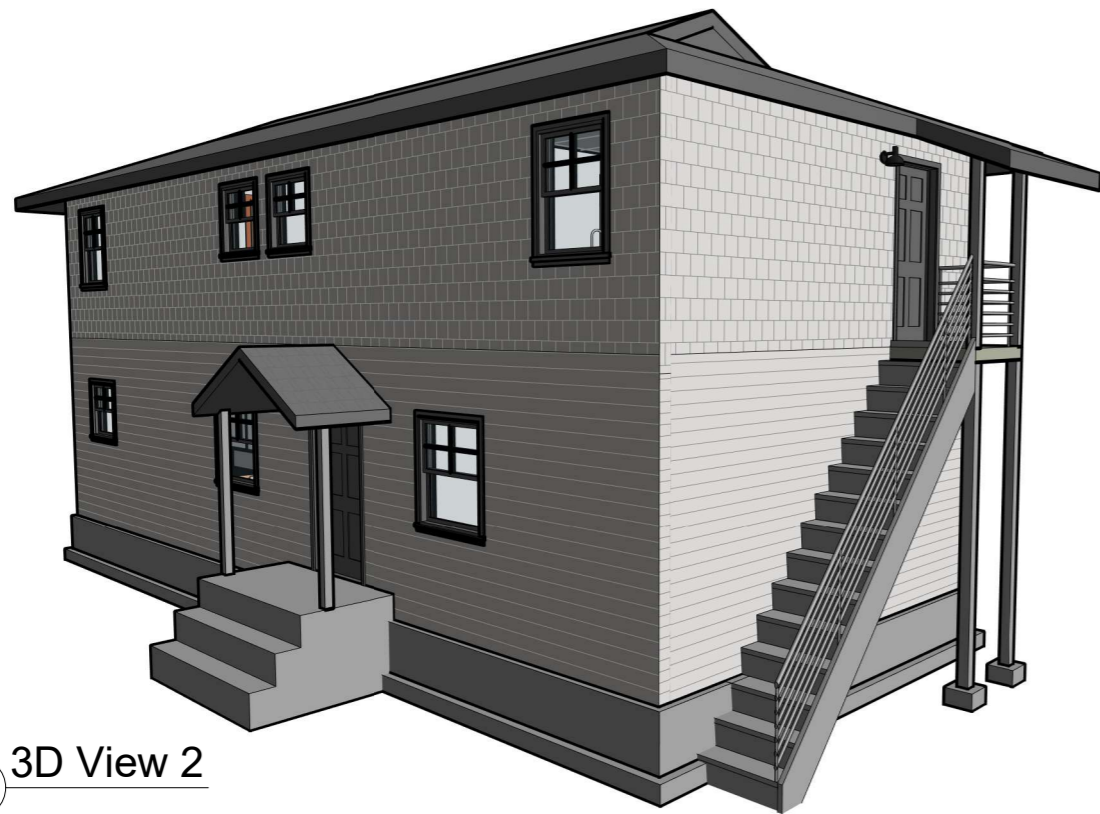

2 3D View 2



3 3D View 3

Sheet List

D1	COVER SHEET
D2	SITE PLAN
D3	GROUND LEVEL
D4	FIRST LEVEL
D5	ROOF PLAN
D6	SECTION
D7	WEST & SOUTH ELEVATION
D8	NORTH & EAST ELEVATION
D9	WINDOW & DOOR SCHEDULES
D10	ELECTRICAL LEGENDS
D11	ELECTRICAL PLAN




PROJECT ADDRESS:
450 Alice Loop-Diana
Fulton-Twaddle




THIS SHEET:
COVER SHEET
DATE:
Issue Date


SHEET NUMBER
D1

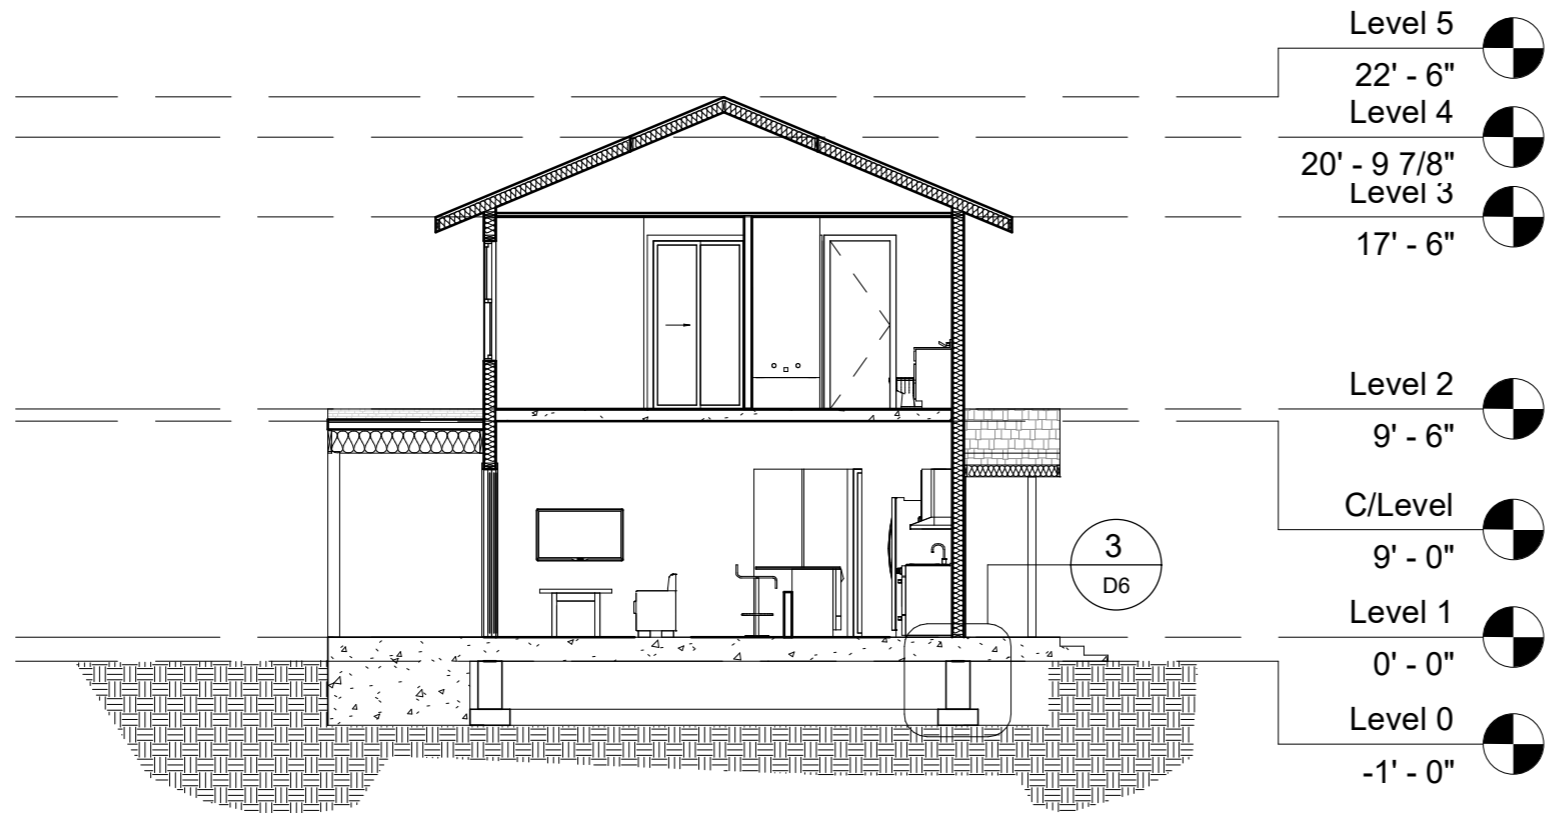

1 Section A
1/8" = 1'-0"

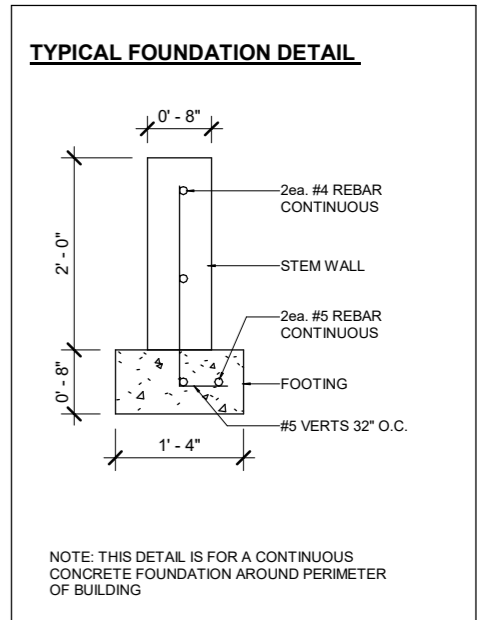

3 FOUNDATION DETAIL
1/2" = 1'-0"

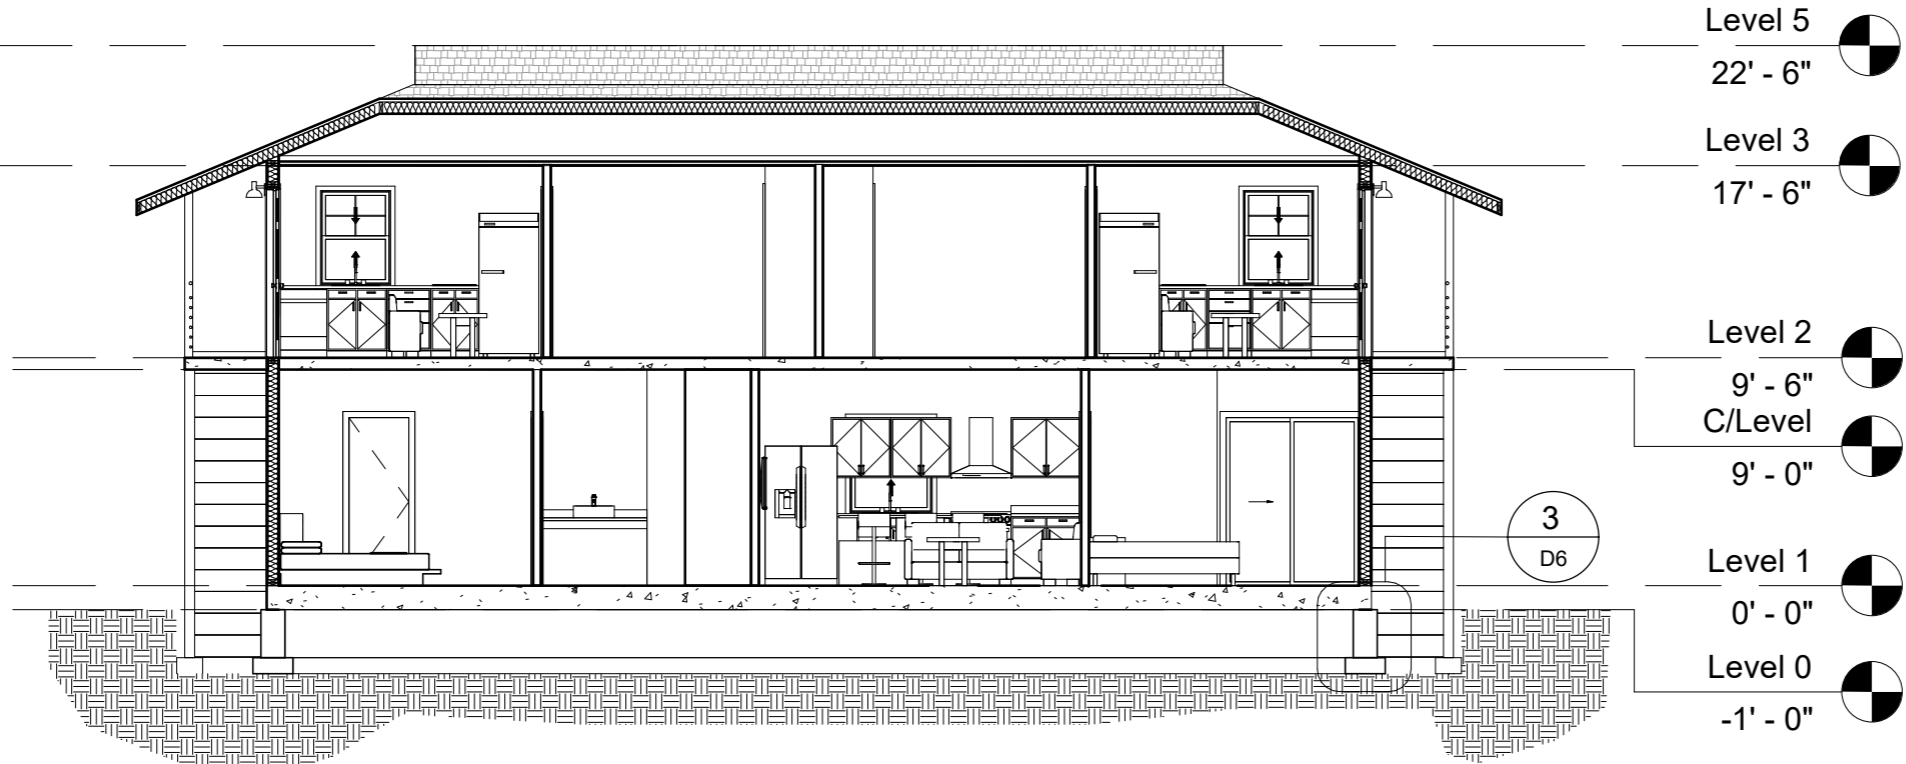

2 Section B
1/8" = 1'-0"



PROJECT ADDRESS:
450 Alice Loop-Diana
Fulton-Twaddle




THIS SHEET:
SECTION
DATE:
Issue Date

SHEET NUMBER
D6



- Level 5 22' - 6"
- Level 4 20' - 9 7/8"
- Level 3 17' - 6"
- Level 2 9' - 6"
- C/Level 9' - 0"
- Level 1 0' - 0"
- Level 0 -1' - 0"

1 West
1/8" = 1'-0"

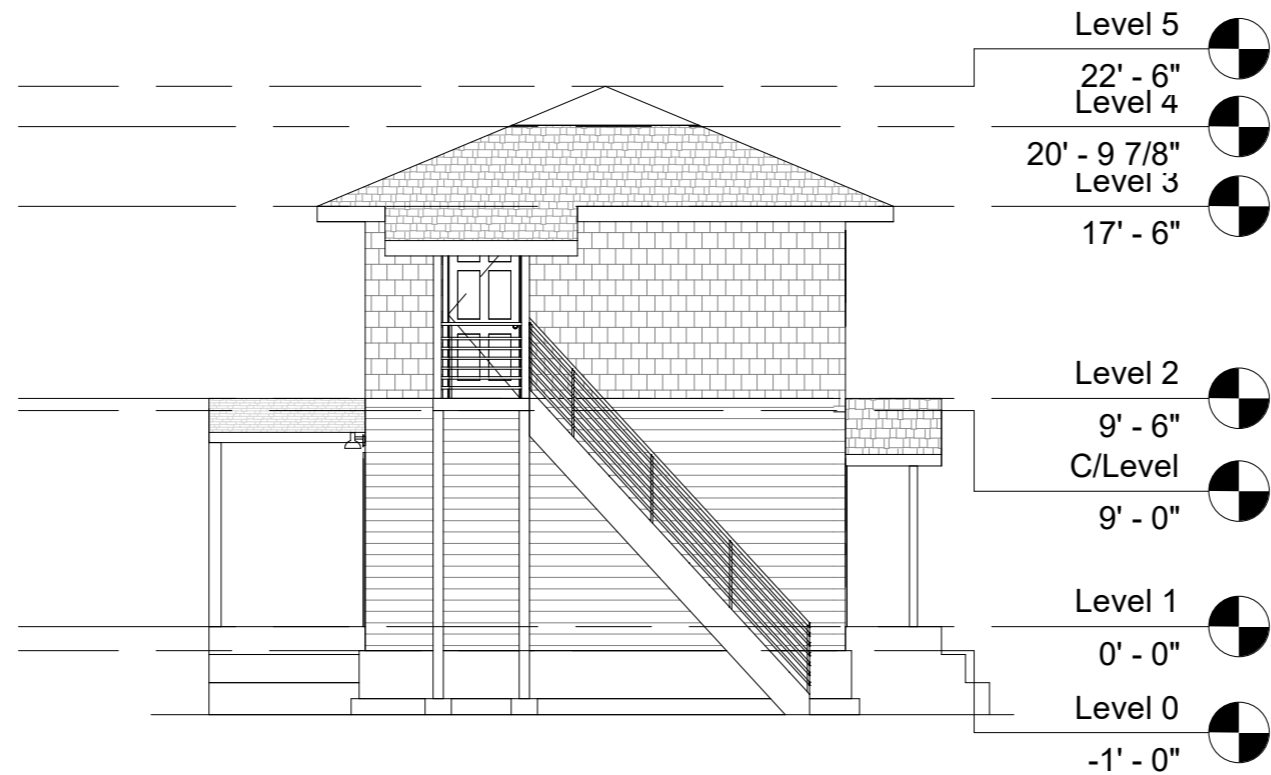

- Level 5 22' - 6"
- Level 4 20' - 9 7/8"
- Level 3 17' - 6"
- Level 2 9' - 6"
- C/Level 9' - 0"
- Level 1 0' - 0"
- Level 0 -1' - 0"

2 South
1/8" = 1'-0"











PROJECT ADDRESS:
450 Alice Loop-Diana
Fulton-Twaddle

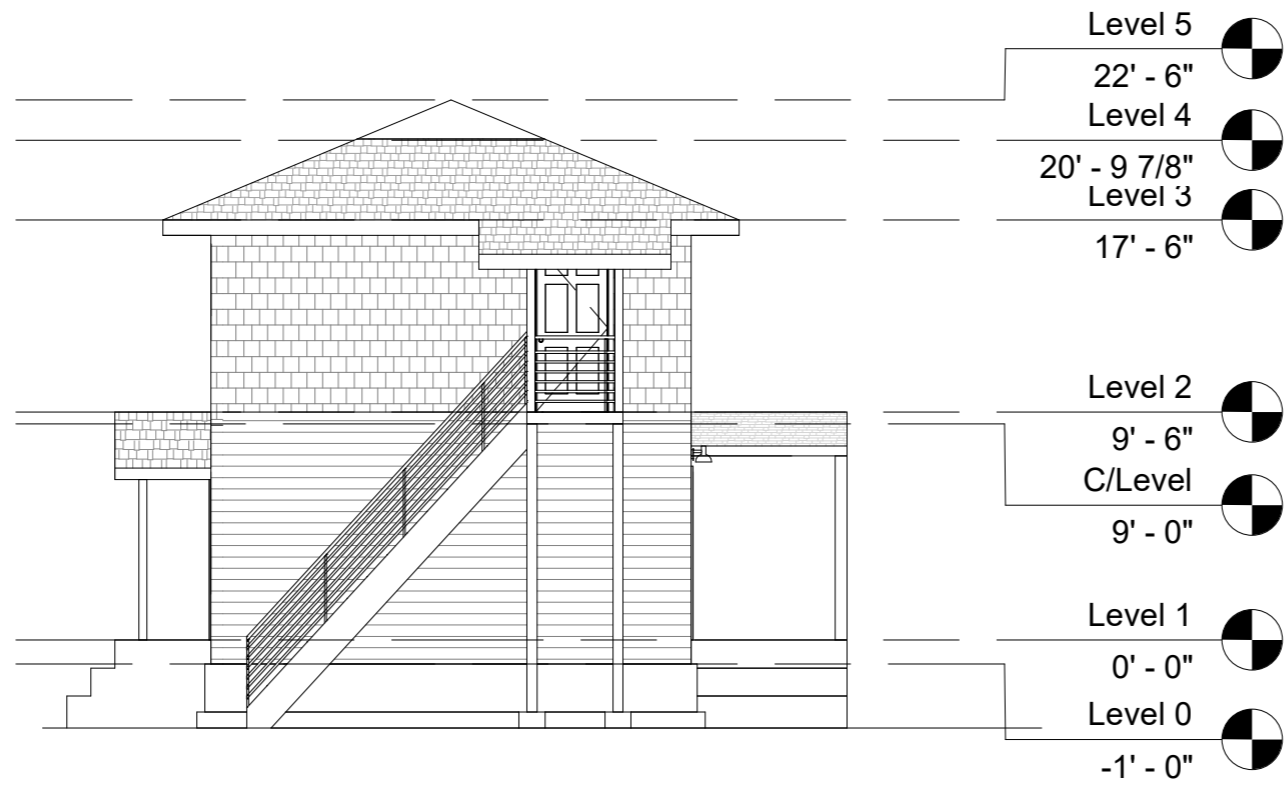

THIS SHEET:
WEST & SOUTH ELEVATION
DATE:
Issue Date








SHEET NUMBER
D7



- Level 5 22' - 6" 
- Level 4 20' - 9 7/8" 
- Level 3 17' - 6" 
- Level 2 9' - 6" 
- C/Level 9' - 0" 
- Level 1 0' - 0" 
- Level 0 -1' - 0" 

1 North
1/8" = 1'-0"



- Level 5 22' - 6" 
- Level 4 20' - 9 7/8" 
- Level 3 17' - 6" 
- Level 2 9' - 6" 
- C/Level 9' - 0" 
- Level 1 0' - 0" 
- Level 0 -1' - 0" 

2 East
1/8" = 1'-0"



PROJECT ADDRESS:
450 Alice Loop-Diana
Fulton-Twaddle



THIS SHEET:
NORTH & EAST ELEVATION
DATE:
Issue Date

SHEET NUMBER
D8